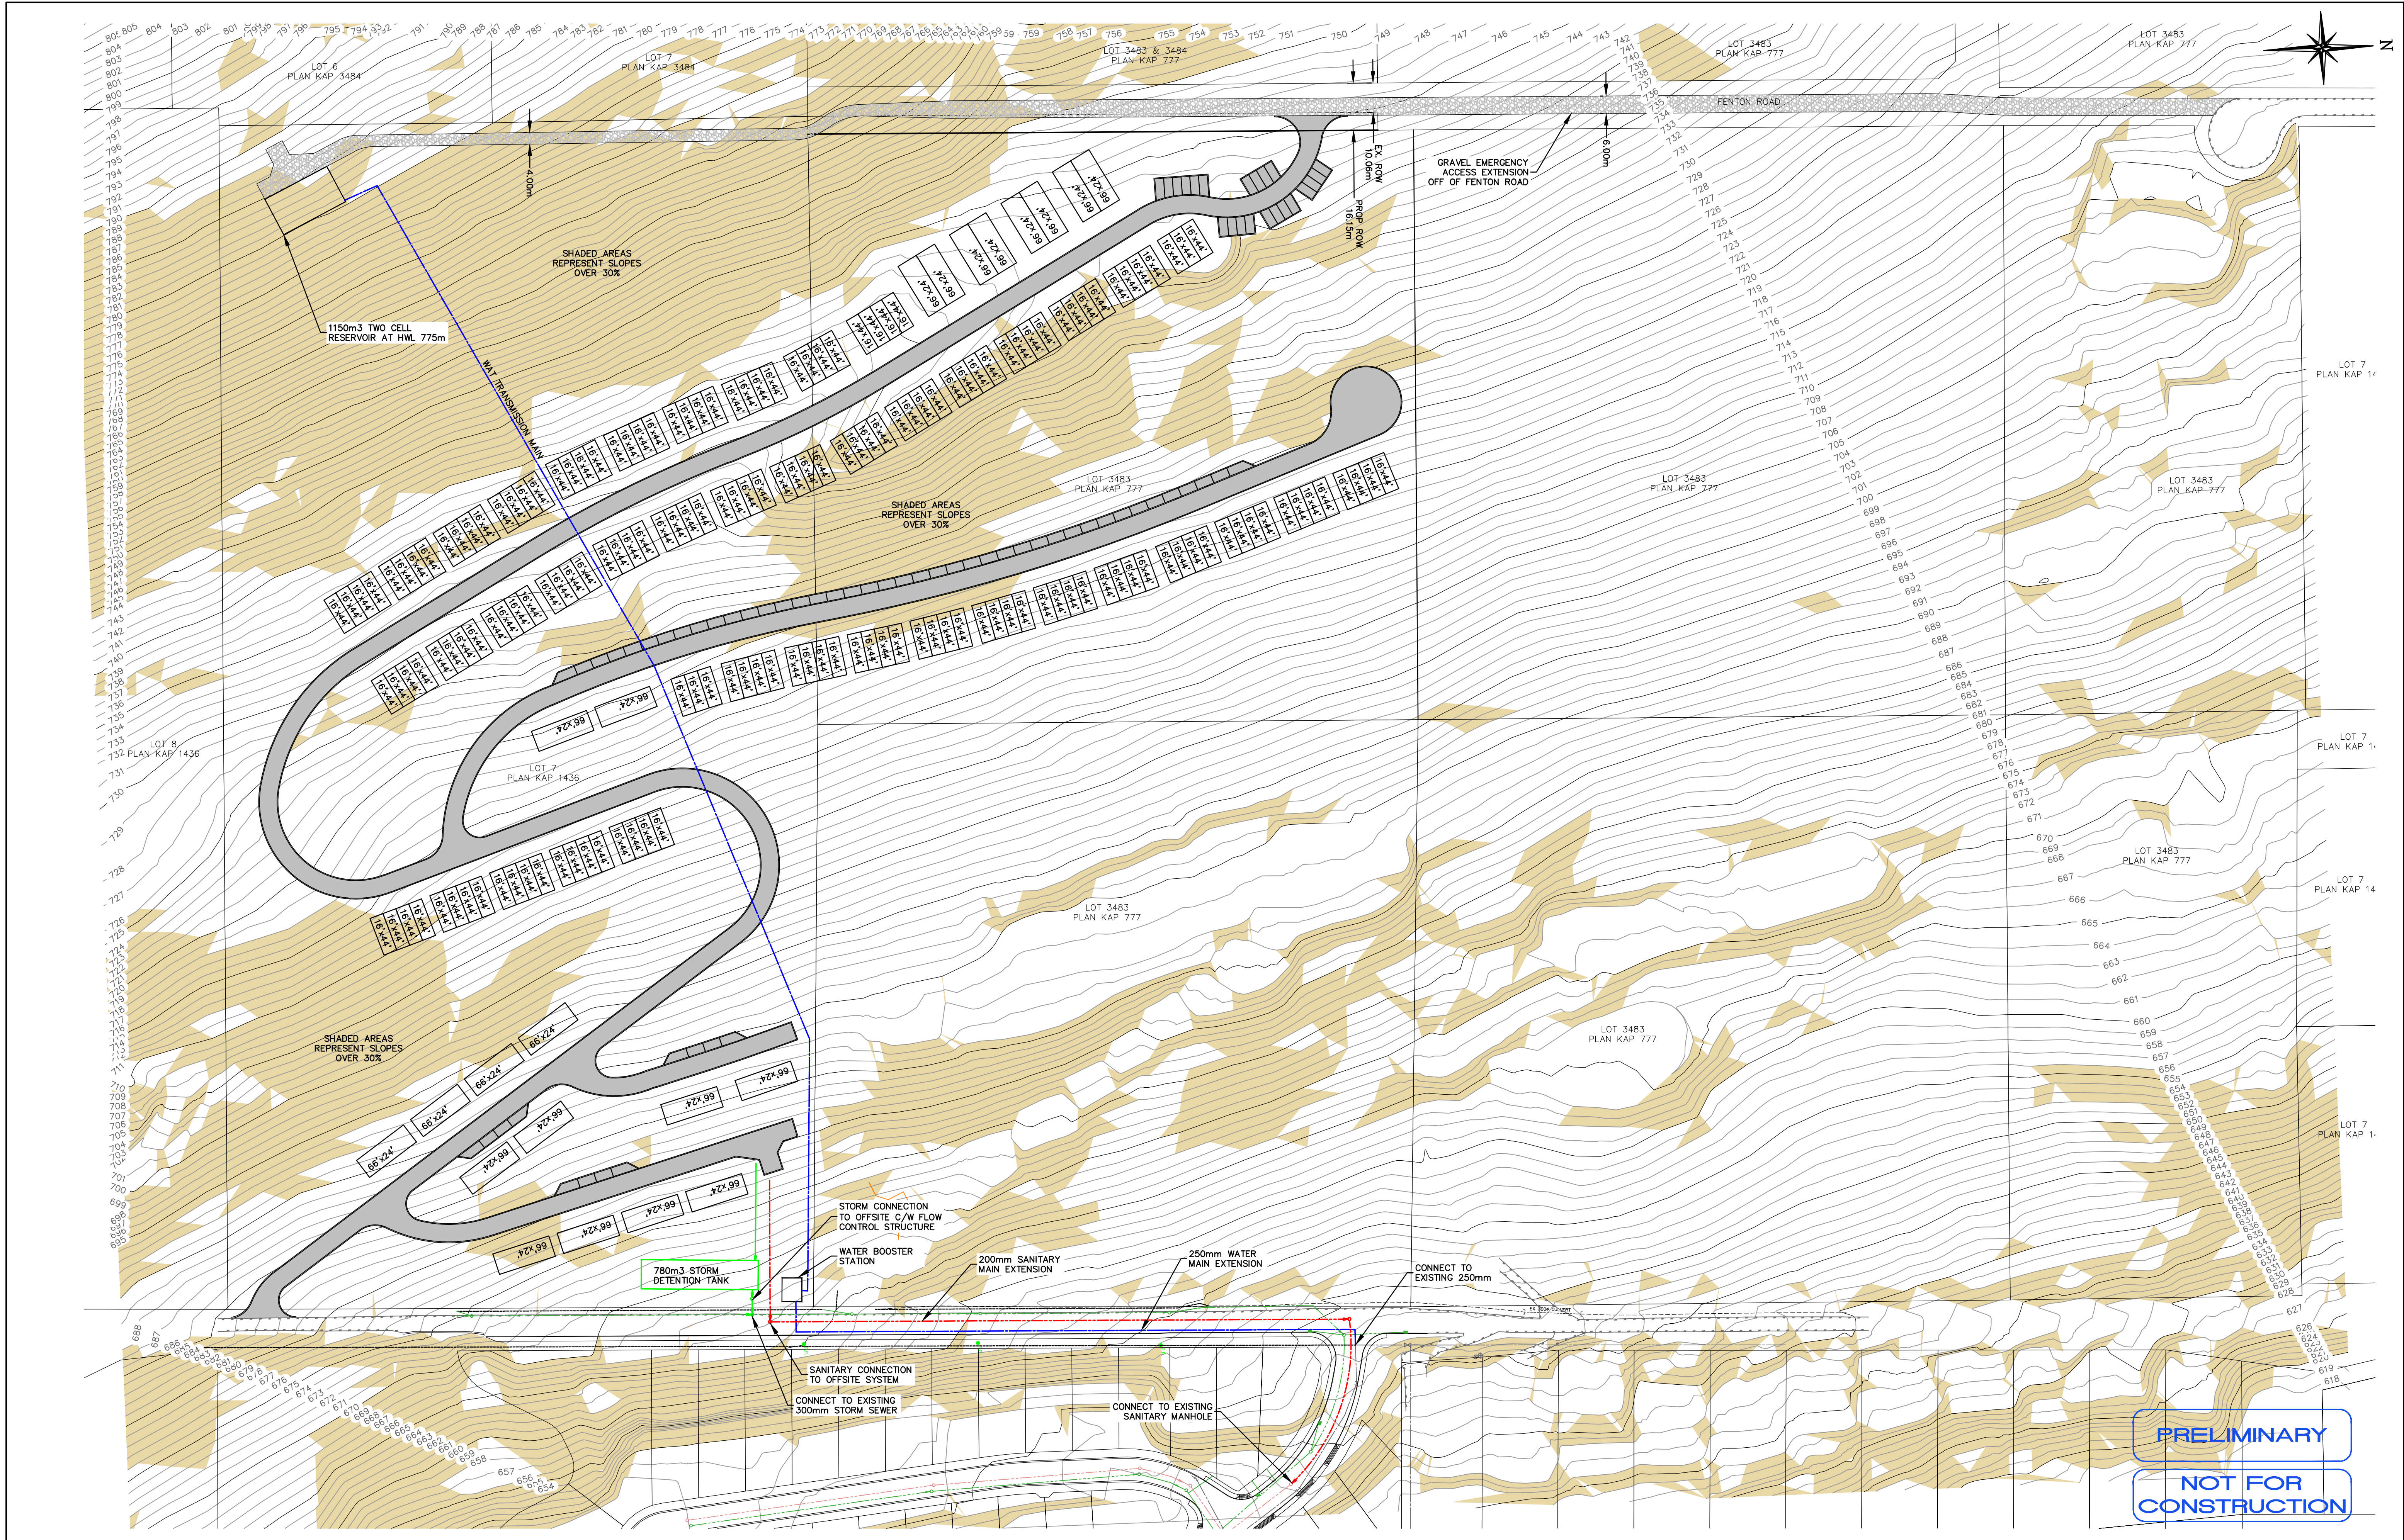


PRELIMINARY
NOT FOR CONSTRUCTION

LEGEND

WATER		MANHOLE		I.C.	
SANITARY SEWER		POWER POLE		C.S.	
STORM SEWER		LAMP STANDARD		LPT	
GAS		CATCH BASIN		SERVICE BOX	
UG TELEPHONE		HYDRANT			
UG ELECTRICAL		TREES			

No.	MM/DD/YY	BY	REVISION	Chk'd	No.	MM/DD/YY	BY	REVISION	Chk'd
					1	2023.12.12	GM	FOR REVIEW	

WEST KELOWNA

P.ENG.

DRAWN	KM
DESIGN	GM/KM
APPROVED	TEXT EDIT
DATE	DECEMBER 2023
SCALE	
HORIZ.	1:1000

PROTECH CONSULTING
300 - 3275 Lakeshore Rd Kelowna B.C. PERMIT TO PRACTICE NO.: 1001403
Phone 860-1771

DRAWING NO.	23058-101
REV. NO.	0

HOMEFIELD COMMUNITIES
GATES ROAD DEVELOPMENT
SITE PLAN

THE LOCATION, NAME AND ADDRESS OF THE CLIENT OR THE PERSON OR FIRM FOR WHOM THE DRAWING IS PREPARED SHALL BE STATED IN THE TITLE BLOCK OF THE DRAWING. THE LOCATION, NAME AND ADDRESS OF THE ENGINEER OR FIRM FOR WHOM THE DRAWING IS PREPARED SHALL BE STATED IN THE TITLE BLOCK OF THE DRAWING.